


Dine College
 Shiprock South Campus Library
 Navajo Route 570
 Shiprock, NM 87420

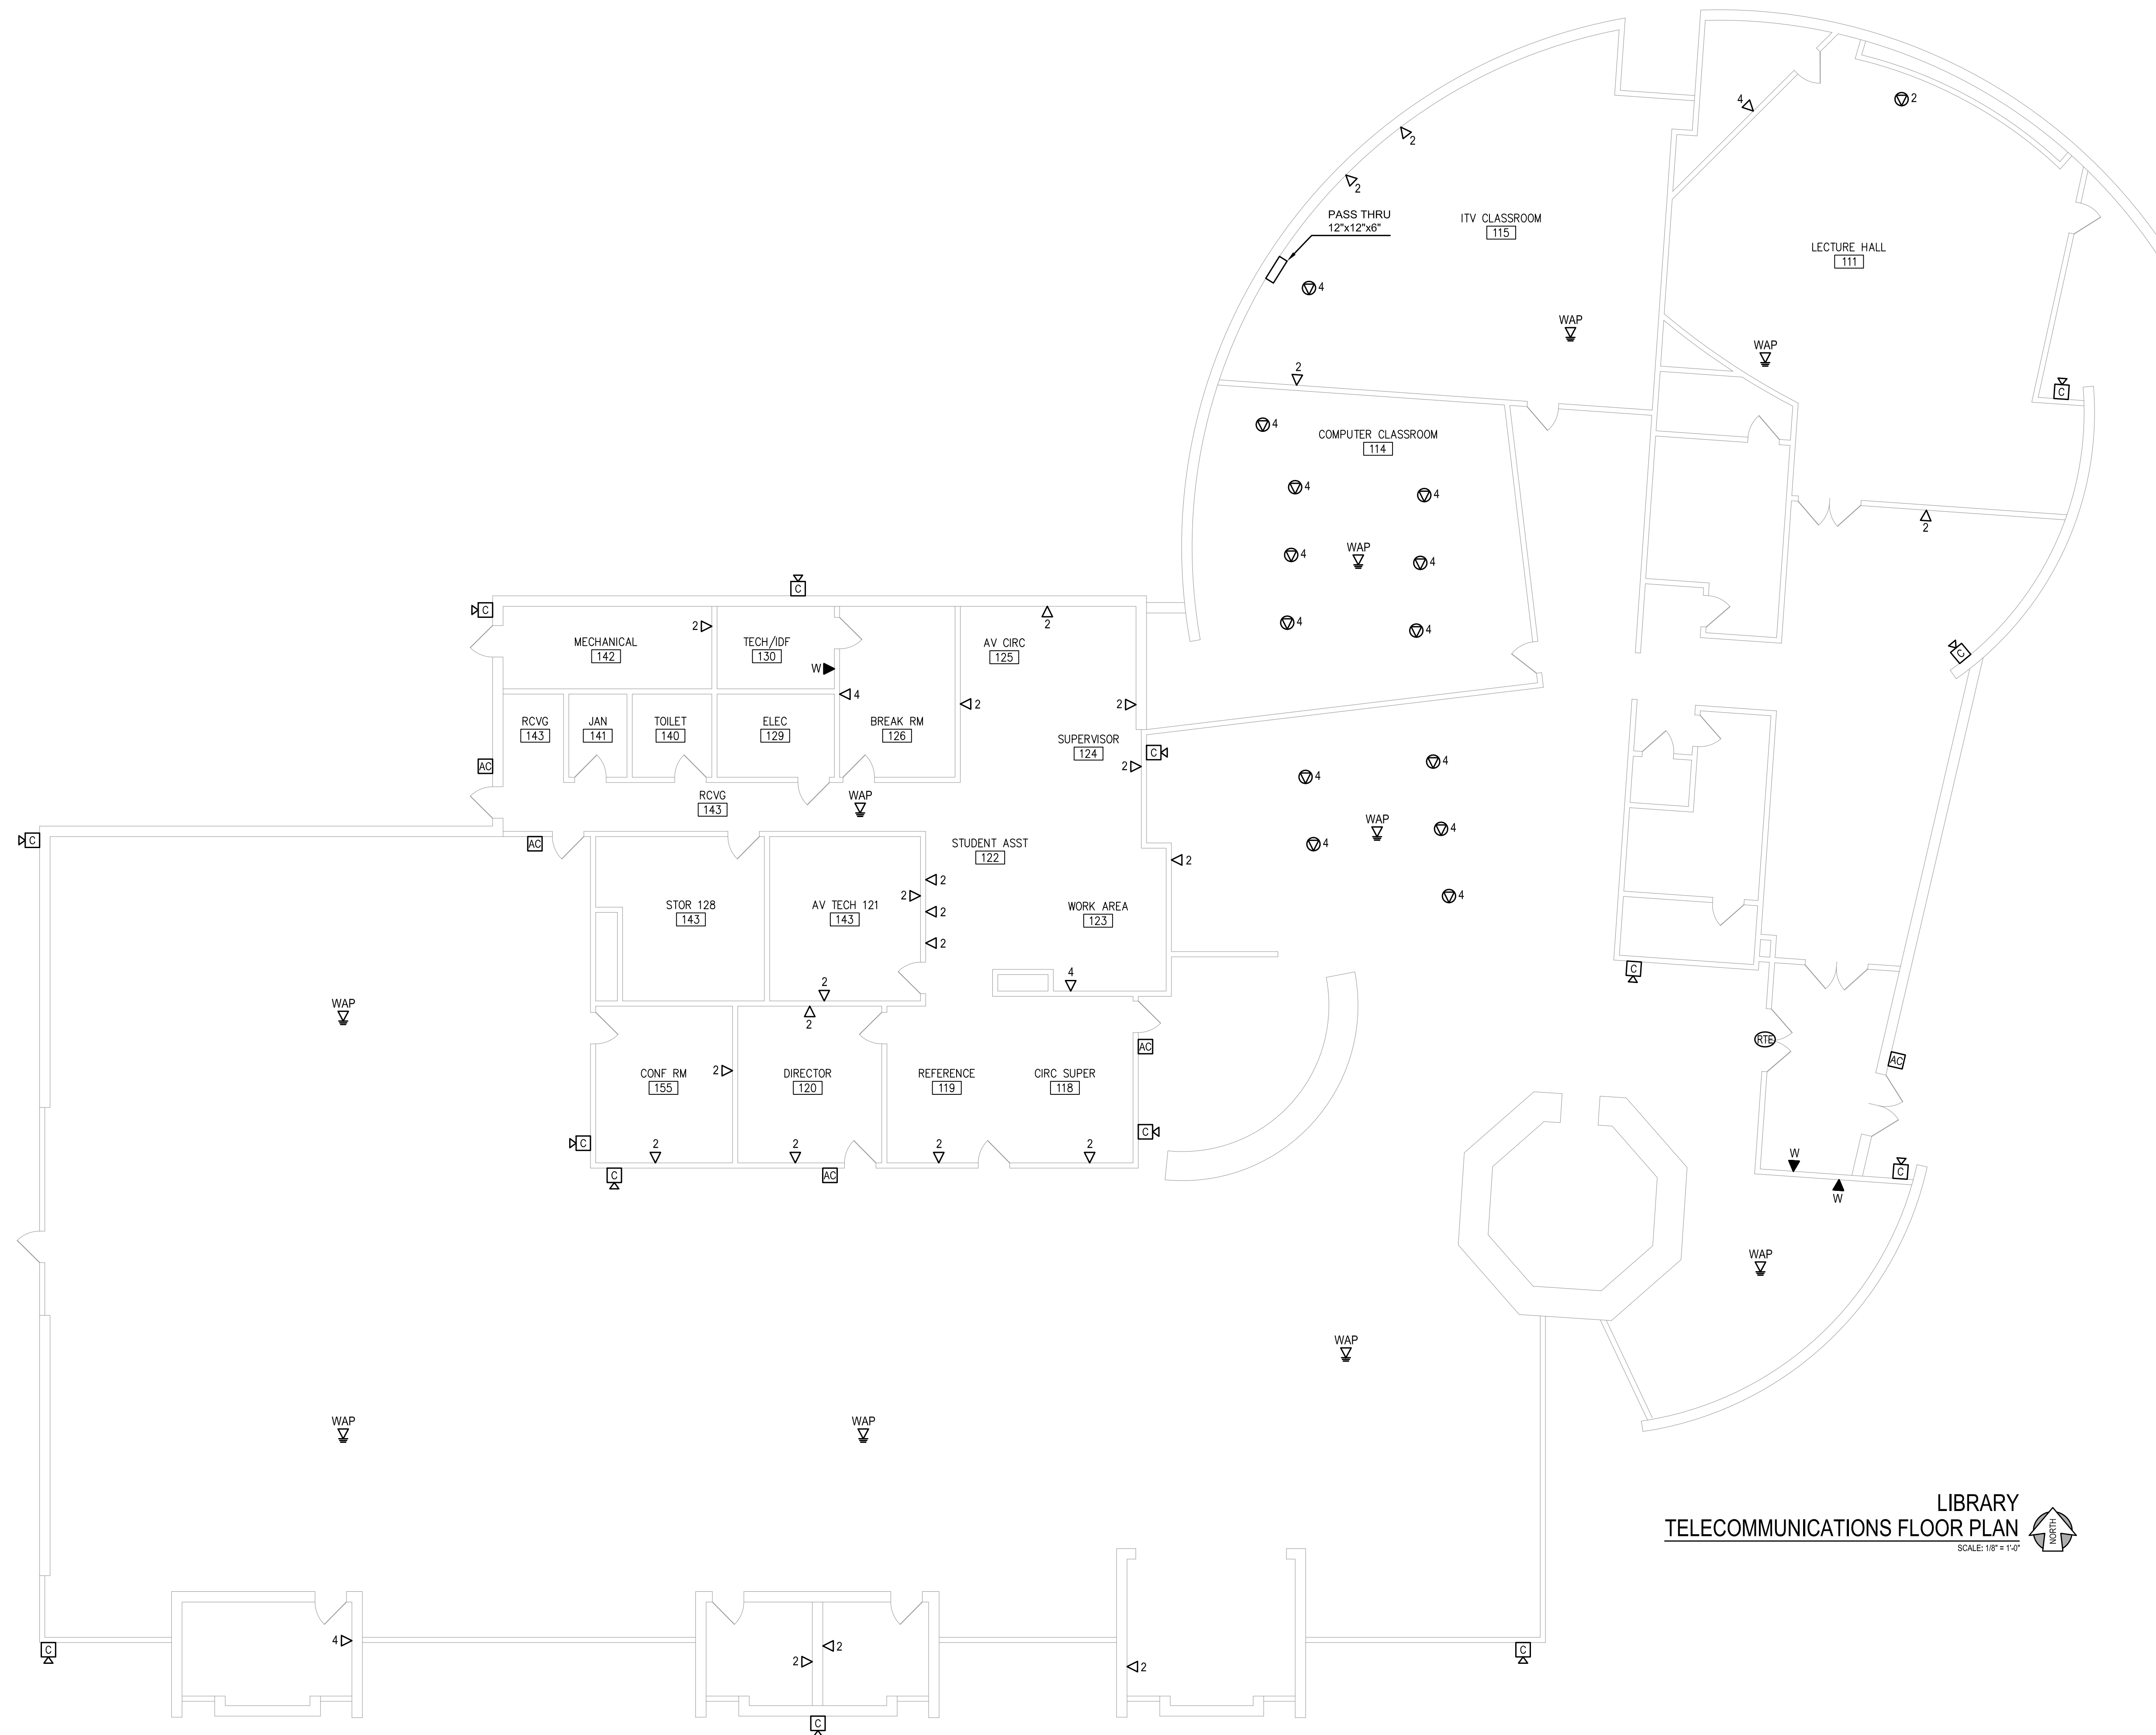

SYMBOL LEGEND

- ▽ ONE (1) DATA
- ▽² TWO (2) DATA
- ▽⁴ FOUR (4) DATA
- ▼^W ONE (1) WALL PHONE
- WAP ONE (1) WIRELESS ACCESS POINT
- ⊙⁴ FOUR (4) DATA - FLOOR BOX
- ⊙^{RTB} ONE (1) REQUEST TO EXIT
- ⊙^{AC} ONE (1) ACCESS CONTROL
- ⊙^C ONE (1) CAMERA

DRAWN BY SDSI (CCS)

APPROVED BY SG

SHEET NAME
 TELECOMMUNICATIONS
 FLOOR PLAN

SHEET

T1.11

LIBRARY
 TELECOMMUNICATIONS FLOOR PLAN
 SCALE: 1/8" = 1'-0"